


NUMBRING PLAN OF BLOCK C & D M.I.G. B (B+S+9) SEC- 14 E MARWAR APARTMENT
CHOPASNI SCHEME JODHPUR TOTAL FLATS 36+36=72

BLOCK - C				BLOCK - D			
FIRST FLOOR	14/C/101	14/C/102	14/C/103	14/C/104	FIRST FLOOR	14/D/101	14/D/102
SECOND FLOOR	14/C/201	14/C/202	14/C/203	14/C/204	SECOND FLOOR	14/D/201	14/D/202
THIRD FLOOR	14/C/301	14/C/302	14/C/303	14/C/304	THIRD FLOOR	14/D/301	14/D/302
FOURTH FLOOR	14/C/401	14/C/402	14/C/403	14/C/404	FOURTH FLOOR	14/D/401	14/D/402
FIFTH FLOOR	14/C/501	14/C/502	14/C/503	14/C/504	FIFTH FLOOR	14/D/501	14/D/502
SIXTH FLOOR	14/C/601	14/C/602	14/C/603	14/C/604	SIXTH FLOOR	14/D/601	14/D/602
SEVENTH FLOOR	14/C/701	14/C/702	14/C/703	14/C/704	SEVENTH FLOOR	14/D/701	14/D/702
EIGHTH FLOOR	14/C/801	14/C/802	14/C/803	14/C/804	EIGHTH FLOOR	14/D/801	14/D/802
NINTH FLOOR	14/C/901	14/C/902	14/C/903	14/C/904	NINTH FLOOR	14/D/901	14/D/902

27/01/11
A.T.P. C.E.II

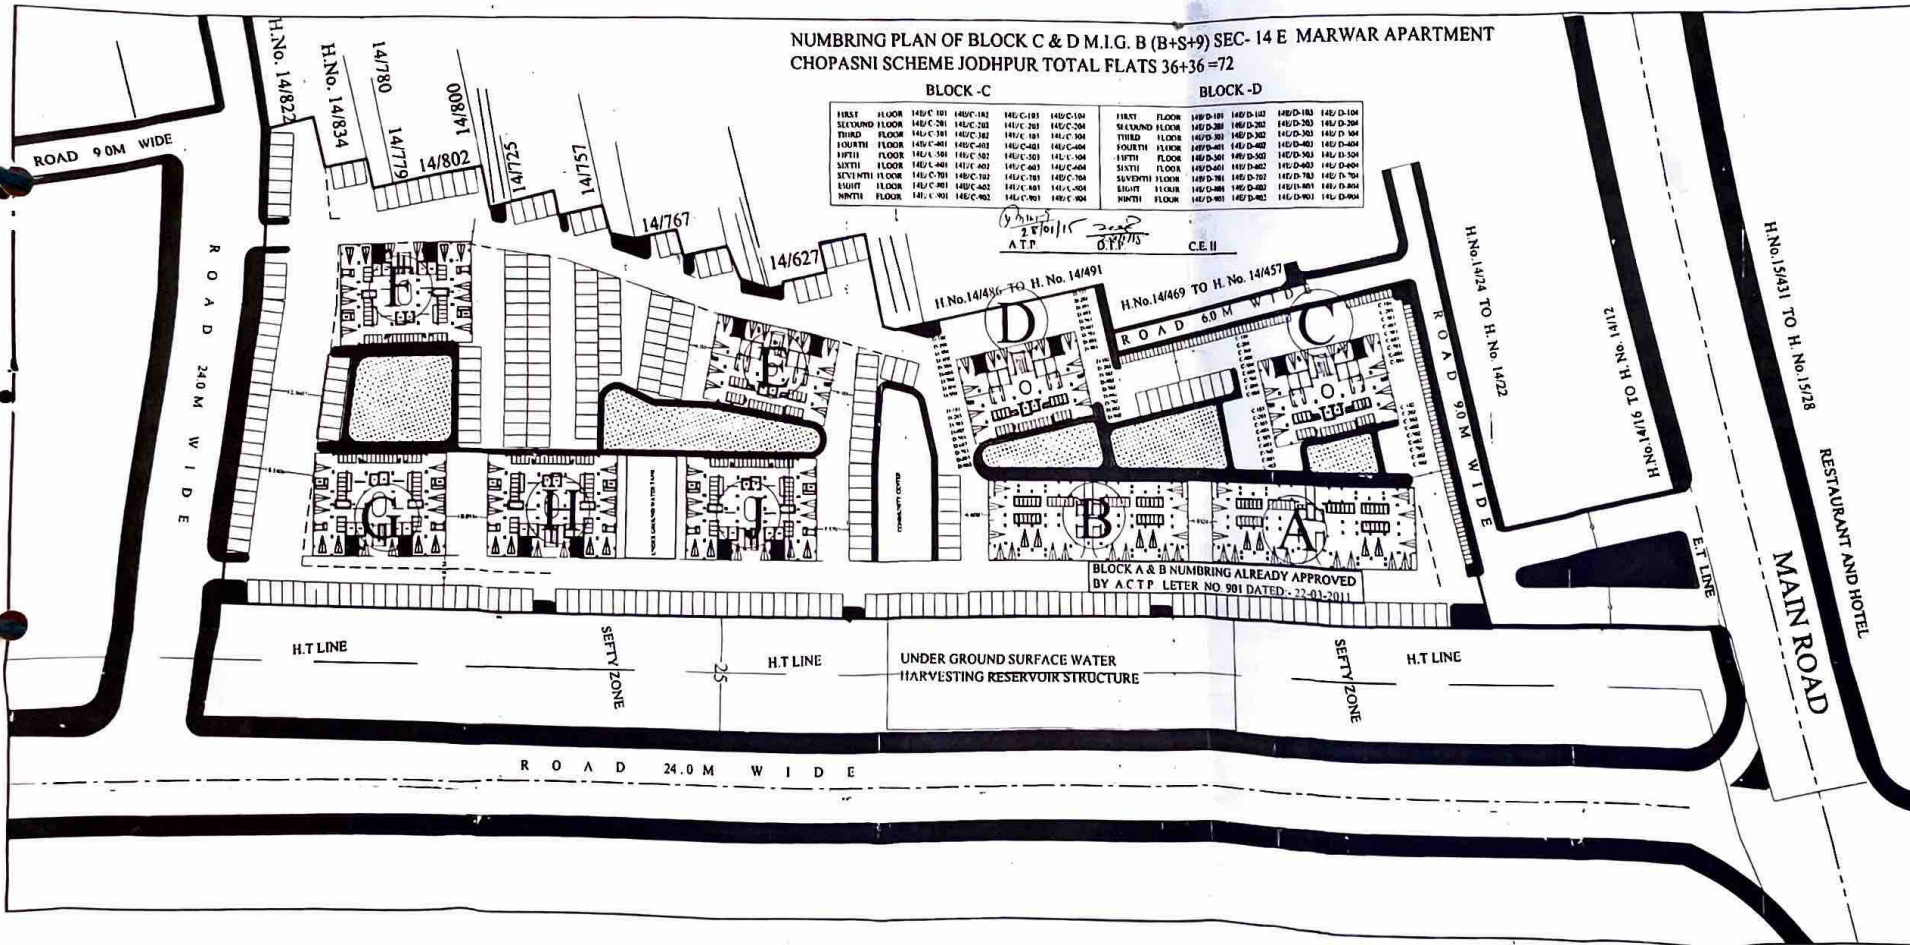

SCHEDULE OF PLOTS

S.N.	TYPE	NO. OF PLOTS
1	14/G I	146
2	14/G II	146
3	14/G III	146
	TOTAL	438

BUILDING PARAMETERS

Plot Area	14600 Sq. M
Building Area	14600 Sq. M
Volume	146000 Cu. M
Height	10 M
Number of Floors	10
Number of Units	72
Number of Apartments	72
Number of Flats	72
Number of Rooms	72
Number of Bathrooms	72
Number of Kitchens	72
Number of Balconies	72
Number of Staircases	72
Number of Lifts	72
Number of Elevators	72
Number of Entrances	72
Number of Exits	72
Number of Windows	72
Number of Doors	72
Number of Paved Areas	72
Number of Green Areas	72
Number of Water Harvesting Structures	72
Number of Sewerage Lines	72
Number of Water Supply Lines	72
Number of Electrical Lines	72
Number of Telephone Lines	72
Number of Gas Lines	72
Number of Fire Lines	72
Number of Drainage Lines	72
Number of Storm Water Lines	72
Number of Sewerage Treatment Plants	72
Number of Water Treatment Plants	72
Number of Power Plants	72
Number of Cooling Towers	72
Number of Air Conditioning Units	72
Number of Heating Units	72
Number of Ventilation Units	72
Number of Exhaust Fans	72
Number of Air Filters	72
Number of Air Cleaners	72
Number of Air Dehumidifiers	72
Number of Air Heaters	72
Number of Air Coolers	72
Number of Air Mixers	72
Number of Air Separators	72
Number of Air Compressors	72
Number of Air Pumps	72
Number of Air Blowers	72
Number of Air Dryers	72
Number of Air Filters	72
Number of Air Cleaners	72
Number of Air Dehumidifiers	72
Number of Air Heaters	72
Number of Air Coolers	72
Number of Air Mixers	72
Number of Air Separators	72
Number of Air Compressors	72
Number of Air Pumps	72
Number of Air Blowers	72
Number of Air Dryers	72

NOTE:-
APPROVED ON URBAN PLAN MEETING HELD ON DATED 11-3-2013 AGENDA NO 11

PROPOSED LAY OUT PLAN OF GROUP HOUSING SCHEME AT MARWAR APARTMENT CHOPASNI SCHEME JODHPUR

DATE	11-03-2013	SCALE	1:1000
DRAWN BY	A.S.P. JODHPUR	CHECKED BY	...
DATE	11-03-2013	SCALE	1:1000
DATE	11-03-2013	SCALE	1:1000

RAJASTHAN HOUSING BOARD